


# 360 ALLSTARS ONYX PRODUCTIONS

BOOMS RIGGED LOW

Please note all lights toured with company run on company dimmers and cables

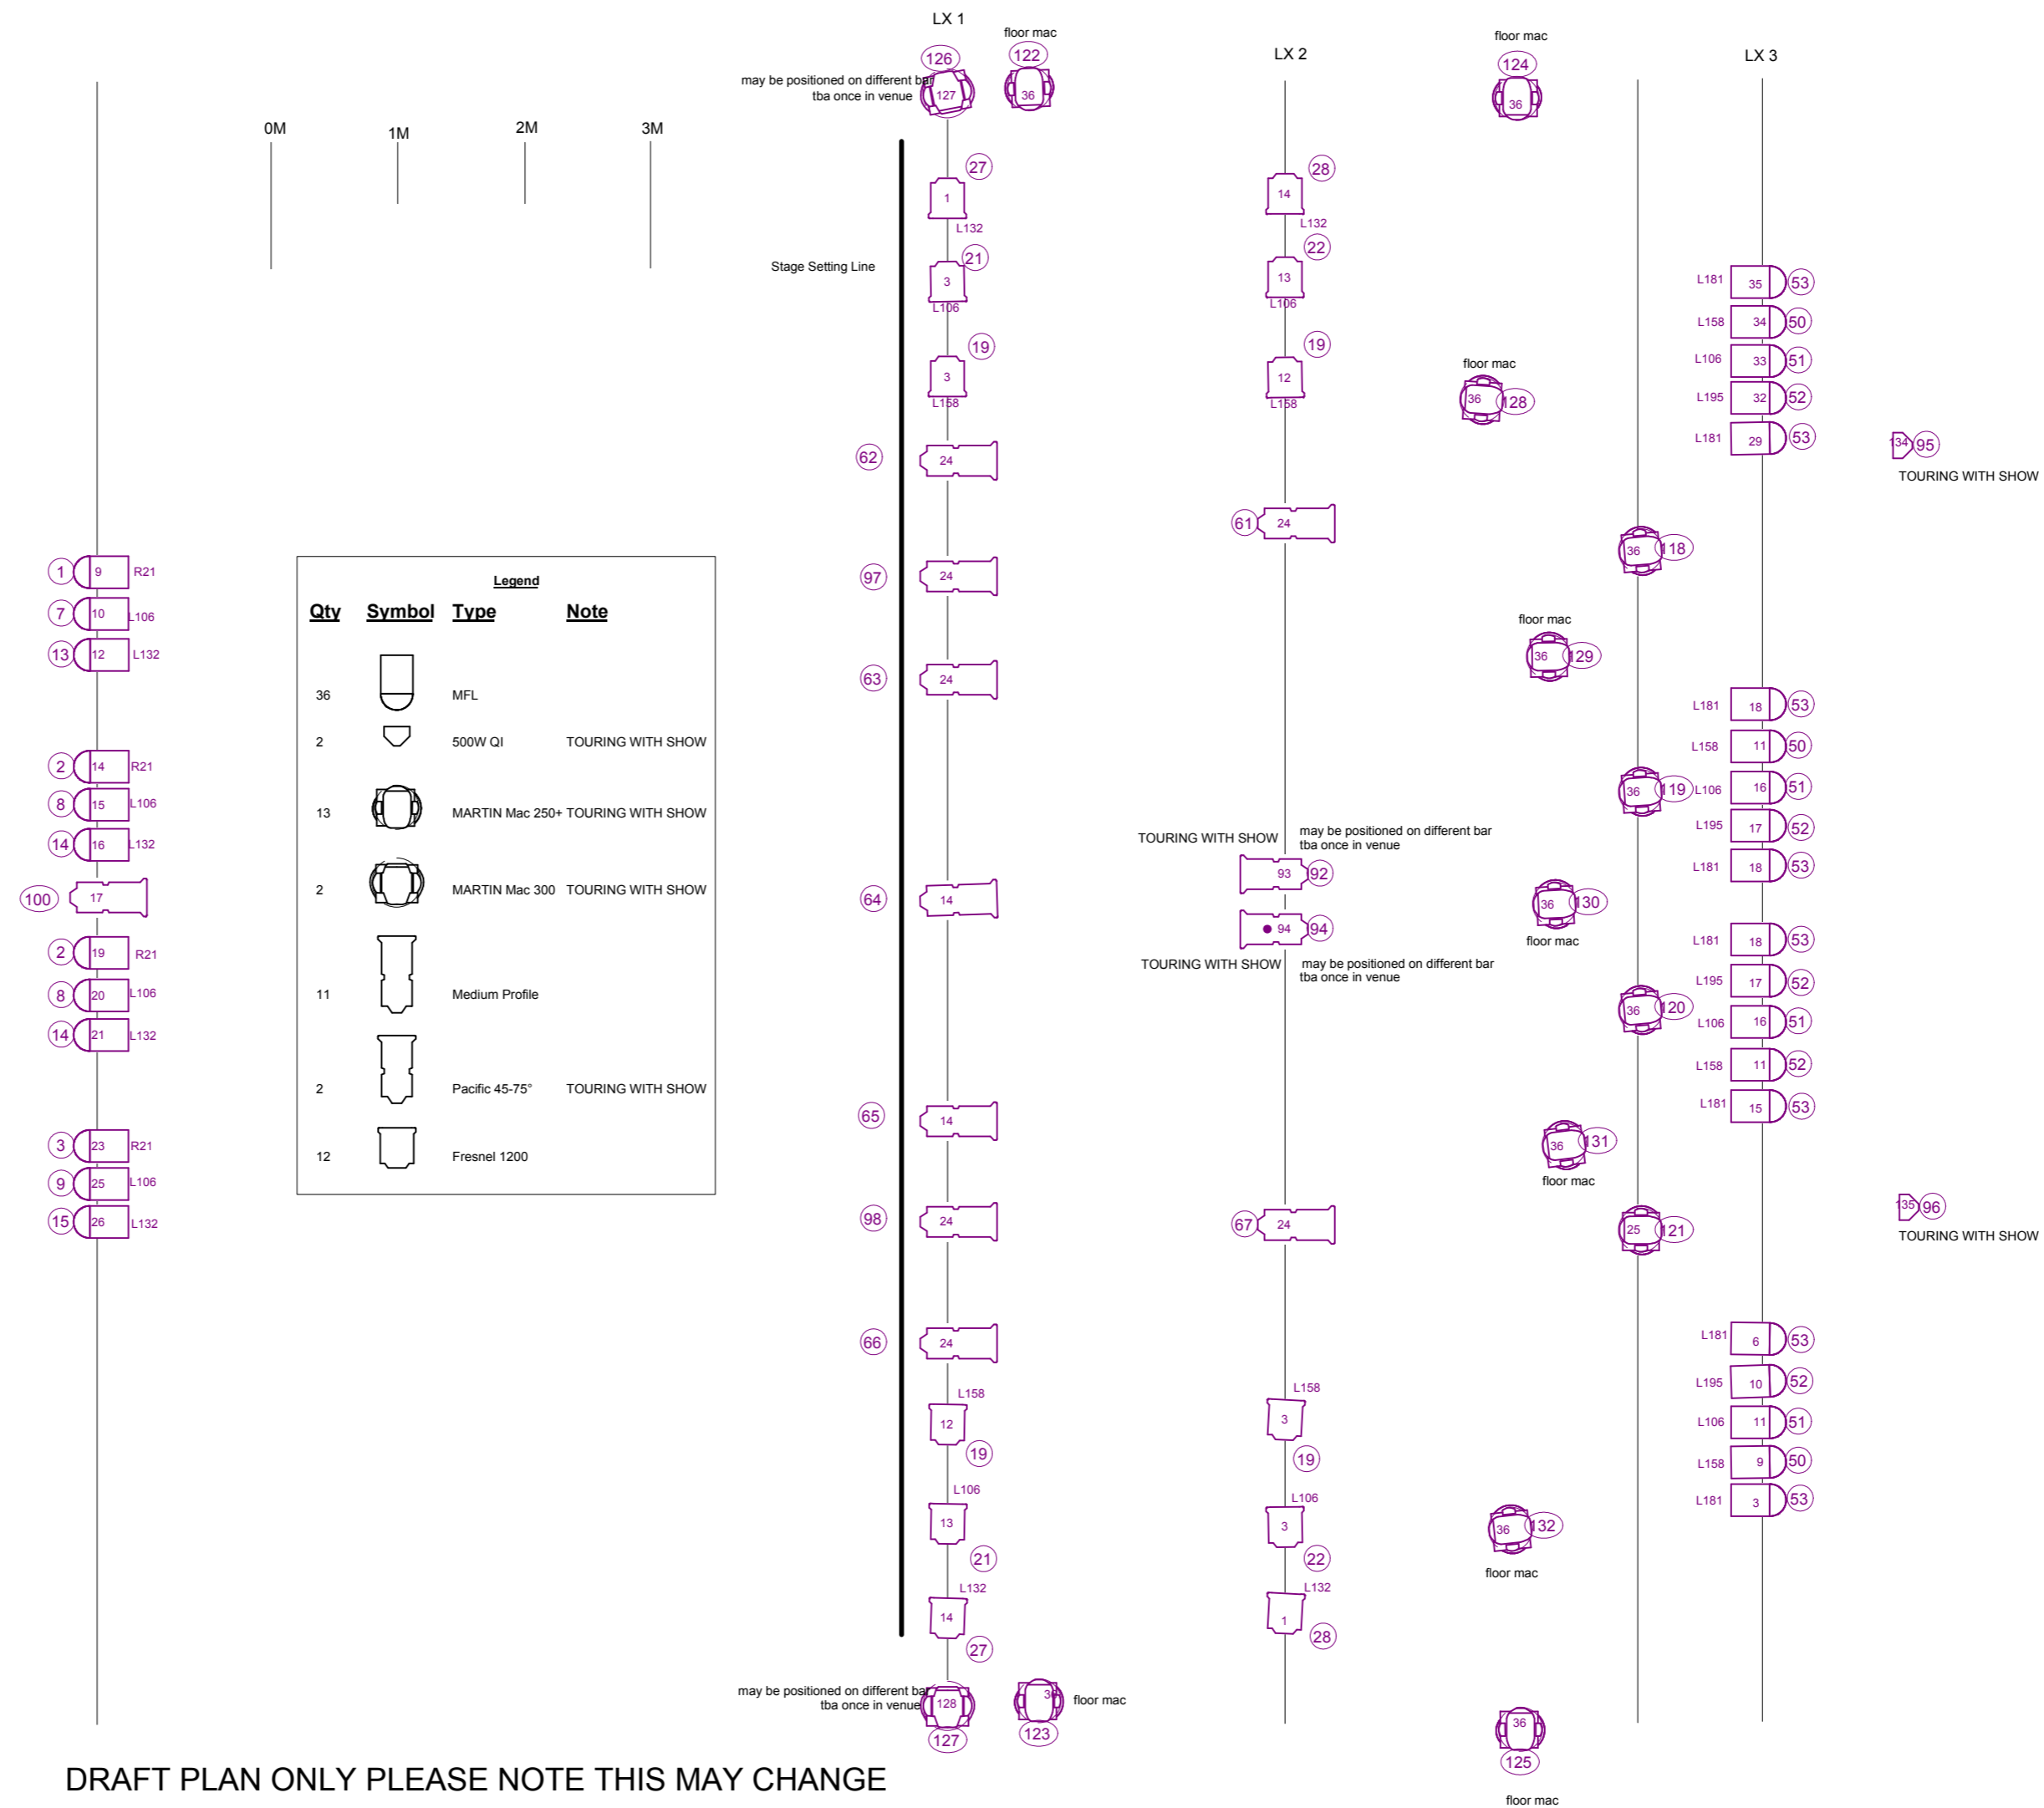

DRAFT PLAN ONLY PLEASE NOTE THIS MAY CHANGE

<b>360 ALLSTARS</b>	
<b>GENERIC TOUR</b>	
Lighting Plan	
Dsgnr: Geoff S	Sheet: 1 of 1
Dir: GENE PETERSON	Scale 1 : 50
DR By: gs	Date: 3/04/2013